


PLAN
SCALE: 1"=40'

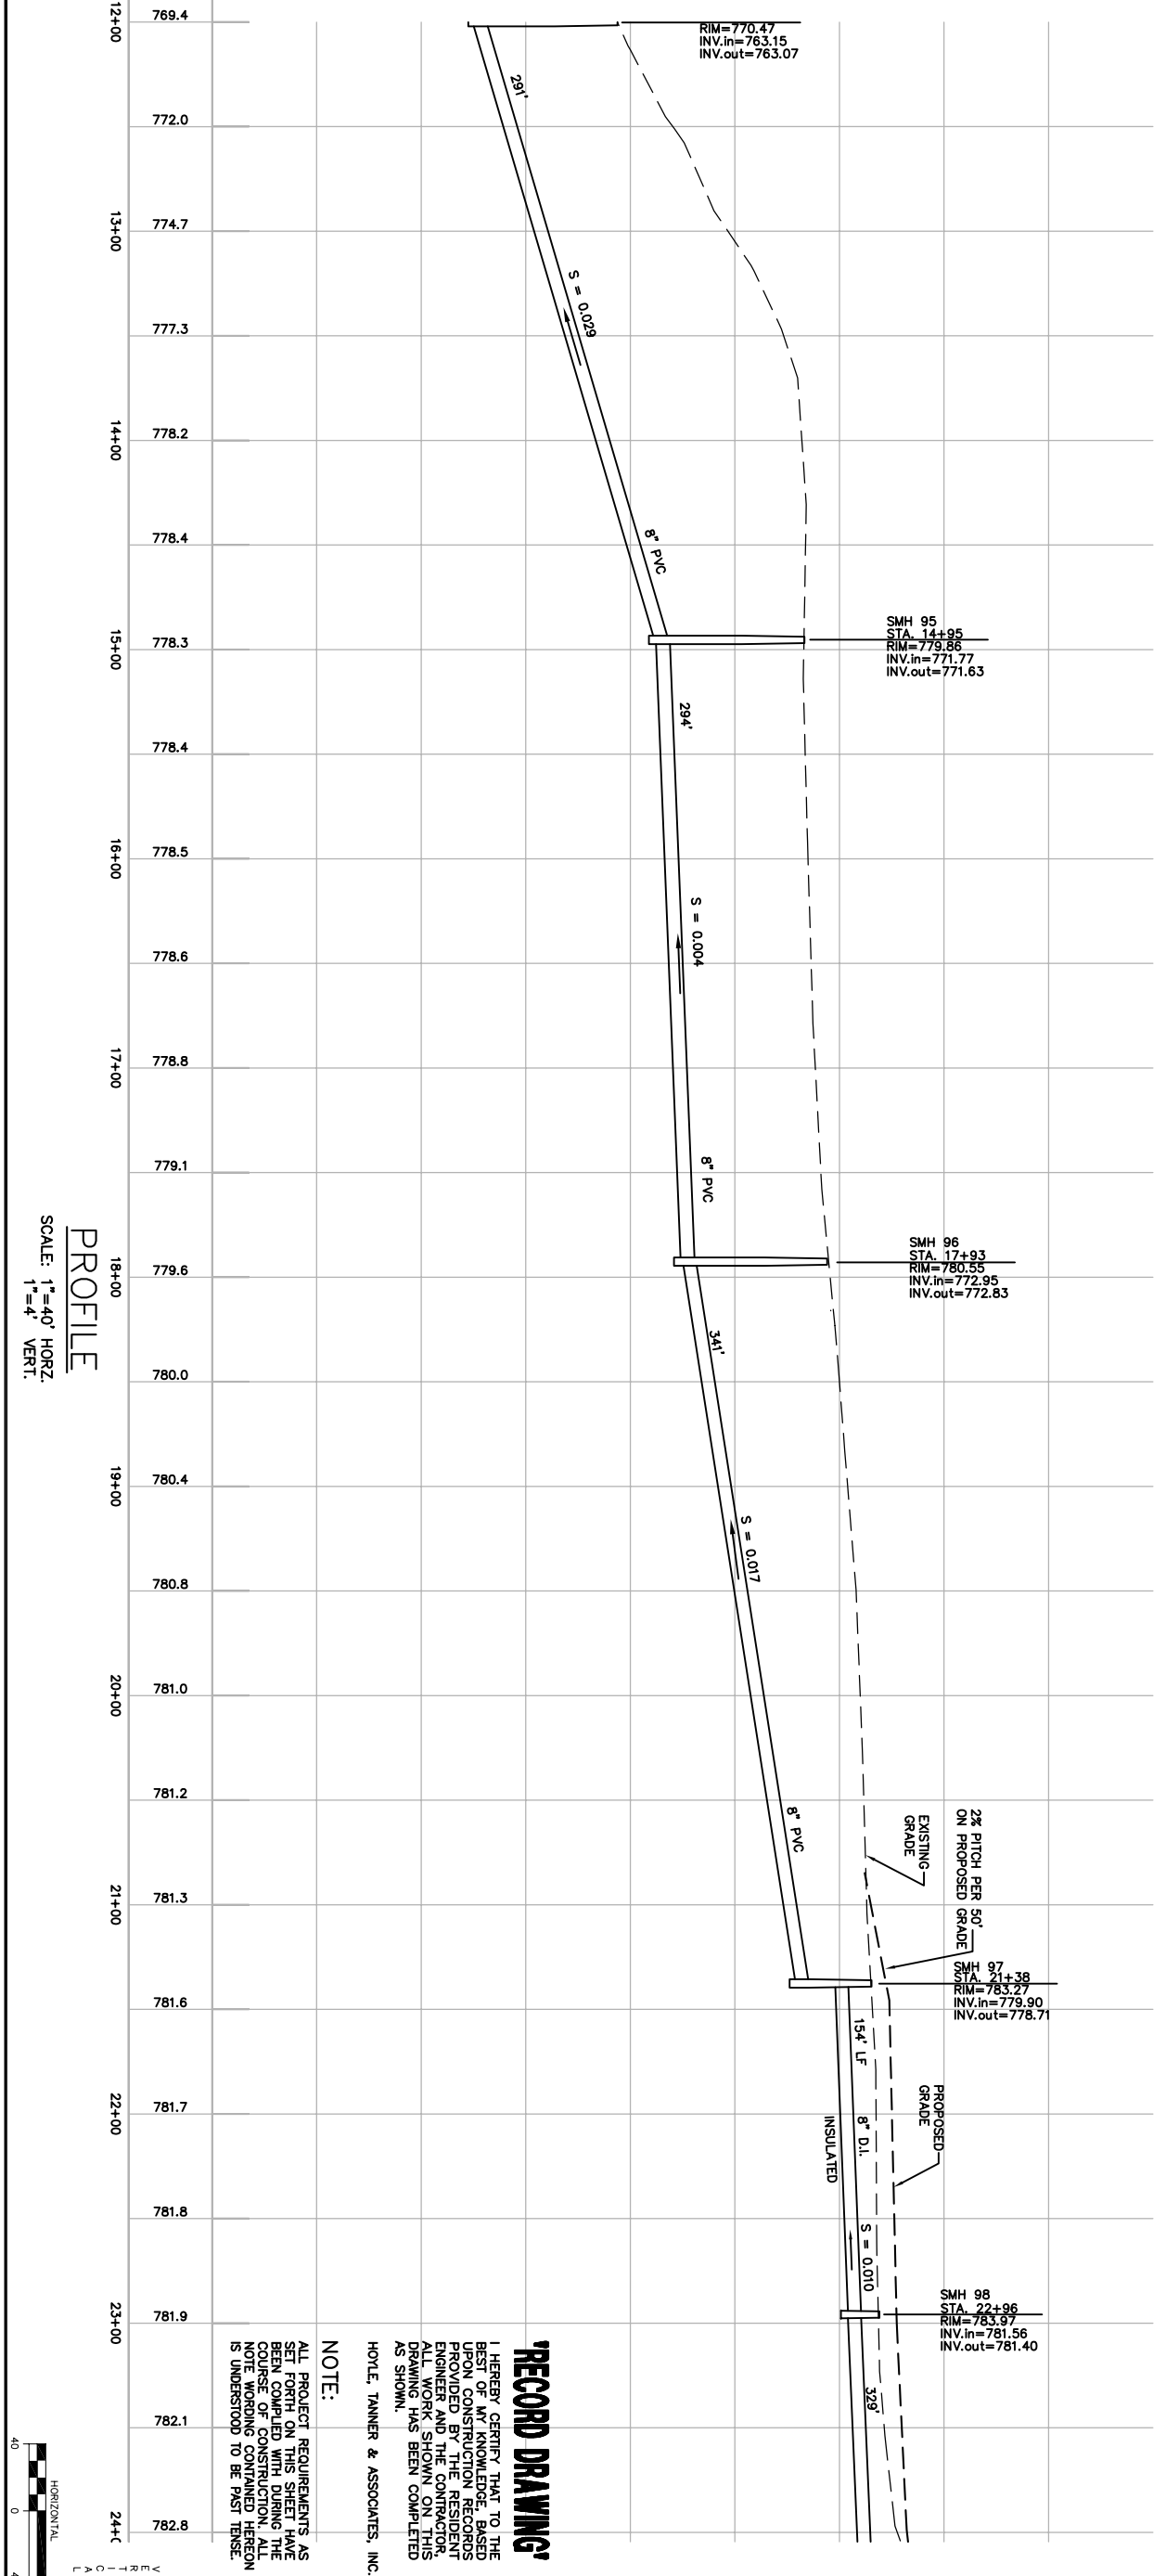

PROFILE
SCALE: 1"=40' HORZ.
1"=4' VERT.

RECORD DRAWING
I HEREBY CERTIFY THAT TO THE BEST OF MY KNOWLEDGE, BASED ON INSPECTION AND RECORDS PROVIDED BY THE CONTRACTOR, ALL WORK SHOWN ON THIS DRAWING HAS BEEN COMPLETED AS SHOWN.
HOYLE, TANNER & ASSOCIATES, INC.

NOTE:
ALL PROJECT REQUIREMENTS AS SET FORTH ON THIS SHEET HAVE BEEN COMPLIED WITH DURING THE COURSE OF CONSTRUCTION. ALL NOTE WORKING CONTAINED HEREON IS UNDERSTOOD TO BE FIRST TENSE.

DRAWING NO. 26	CHERRY VALLEY SEWER DISTRICT LEICESTER, MASSACHUSETTS		Hoyle, Tanner & Associates, Inc. 150 Dow Street • Manchester • New Hampshire 03101 Consulting Engineers		PROJECT NO. 105709	ENGINEER/ARCHITECT			
	PLAN AND PROFILE CHAPEL STREET STA. 12+00 TO 24+00		SCALE: AS SHOWN	DATE: APRIL 2001	DES. BY JAH	DR. BY CAB/RCP	CHKD. BY NLT	DO NOT SCALE DRAWING	1. RECORD DRAWING
SHEET 26 OF 38								REV.	DATE