


PLAN
SCALE: 1"=40'

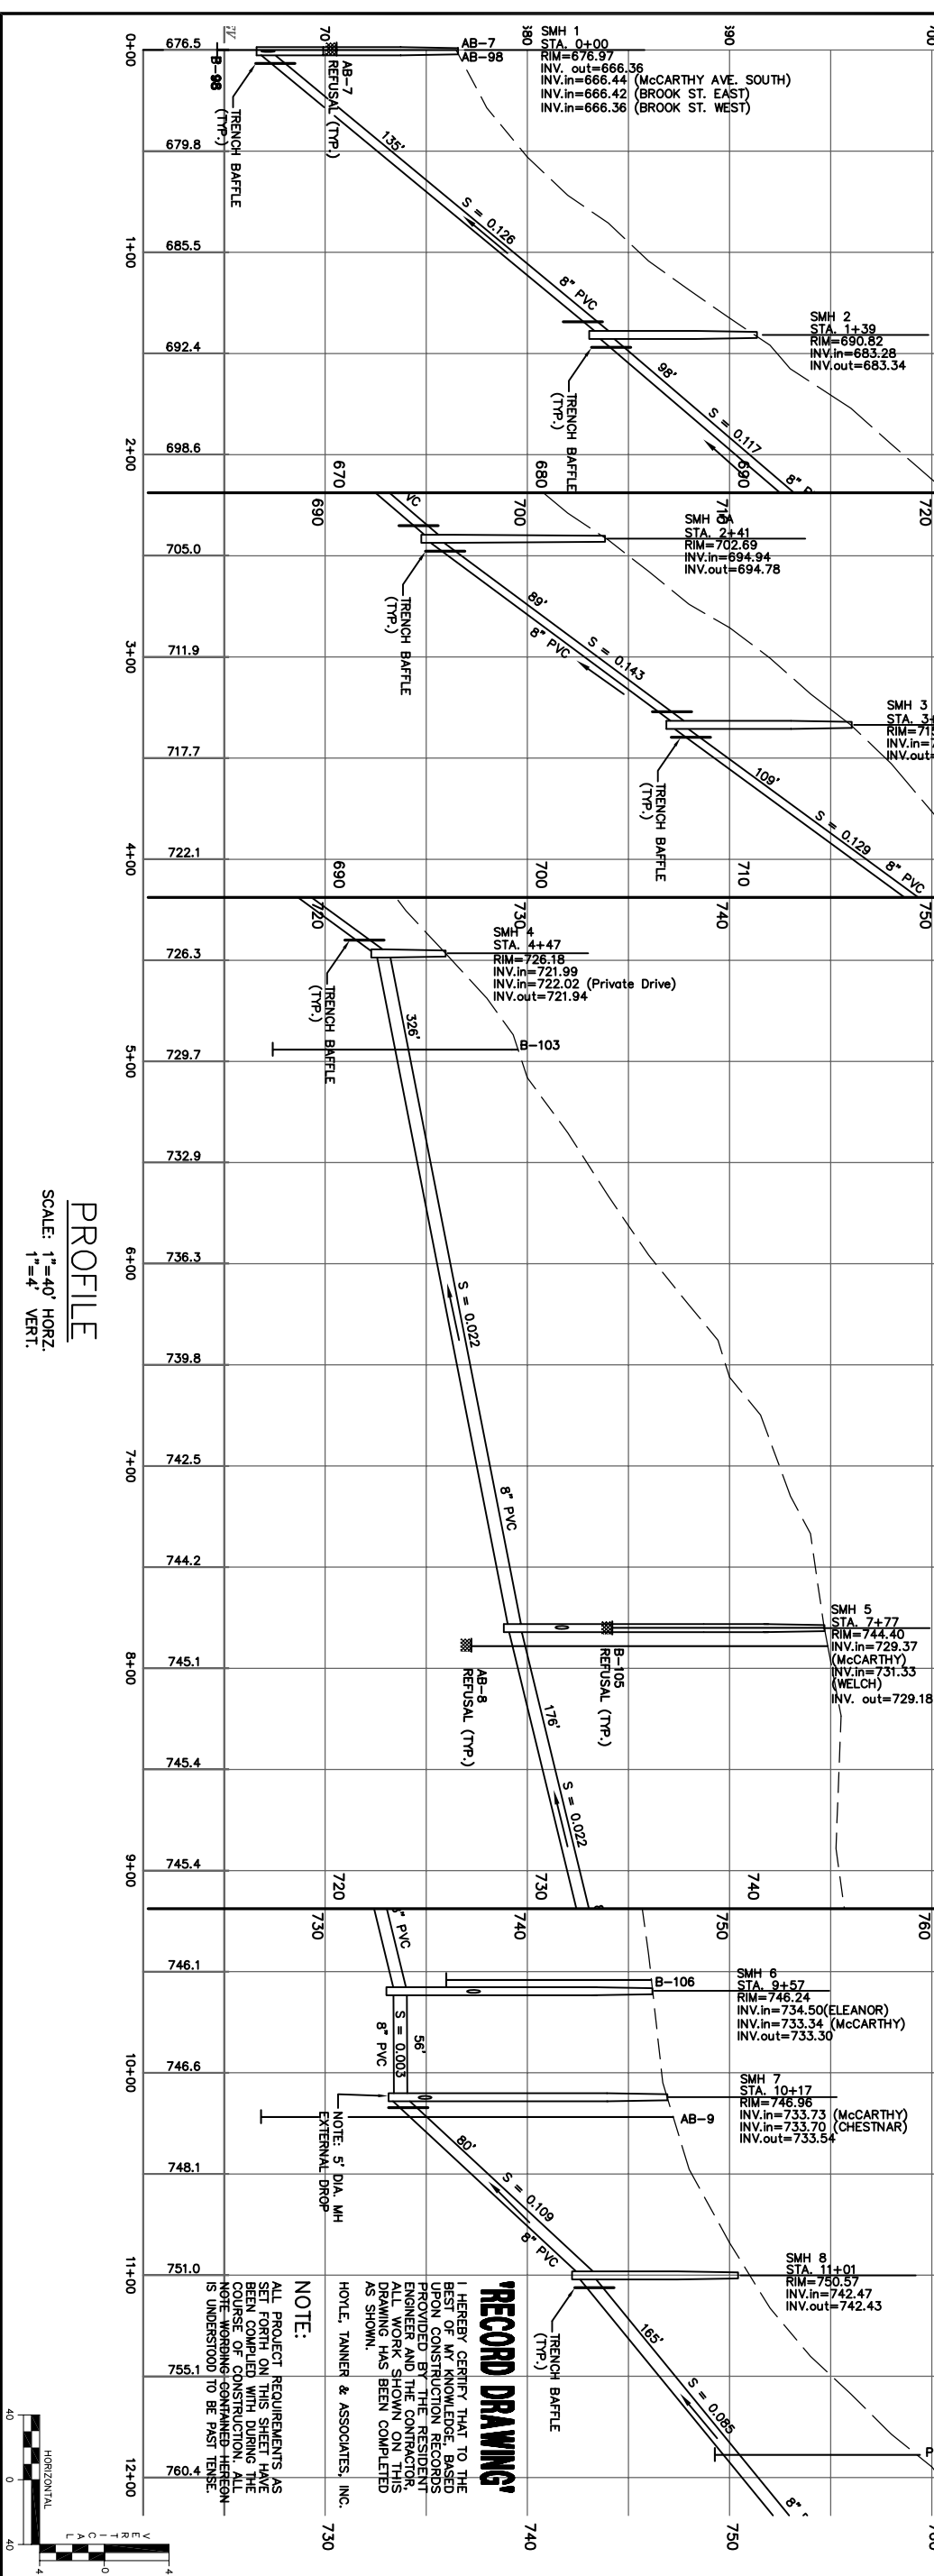

PROFILE
SCALE: 1"=40' HORIZ.
1"=4' VERT.

CHERRY VALLEY SEWER DISTRICT
LEICESTER, MASSACHUSETTS
PLAN AND PROFILE
McCarthy Avenue
0+00 TO 12+00

HTA Hoyle, Tanner & Associates, Inc.
150 Dow Street • Manchester • New Hampshire 03101
Consulting Engineers

SCALE: AS SHOWN DATE: APRIL 2001 DES. BY JAH DR. BY CAB/RCP CHKD. BY NLT

PROJECT NO.	105709	FILE NAME	ABPROF-02
DO NOT SCALE DRAWING	1. RECORD DRAWING	C.B. W.C. W.C. 10/02	
REV.	DESCRIPTION	DR. BY	CHKD. BY

RECORD DRAWING

I HEREBY CERTIFY THAT TO THE BEST OF MY KNOWLEDGE, BASED UPON CONSTRUCTION RECORDS PROVIDED BY THE RESIDENT, ENGINEER AND THE CONTRACTOR, ALL WORK SHOWN ON THIS DRAWING HAS BEEN COMPLETED AS SHOWN.

HOYLE, TANNER & ASSOCIATES, INC.

NOTE:
ALL PROJECT REQUIREMENTS AS SET FORTH ON THIS SHEET HAVE BEEN FULLY COMPLETED. THE COURSE OF CONSTRUCTION ALL NOTE WORKING GOVERNED HEREON IS UNDERSTOOD TO BE PAST TENSE.

NOTE: 5" DIA. MH EXTERNAL DROP