

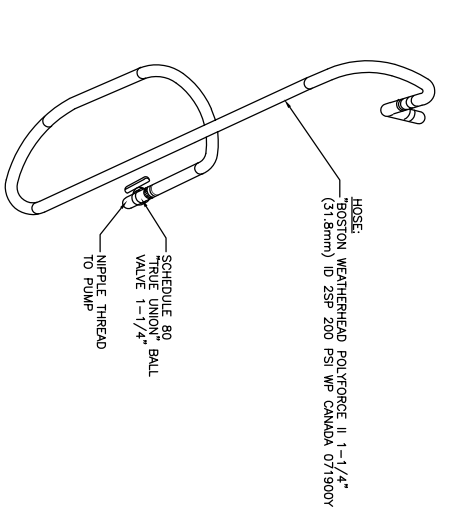



PLAN
NOT TO SCALE

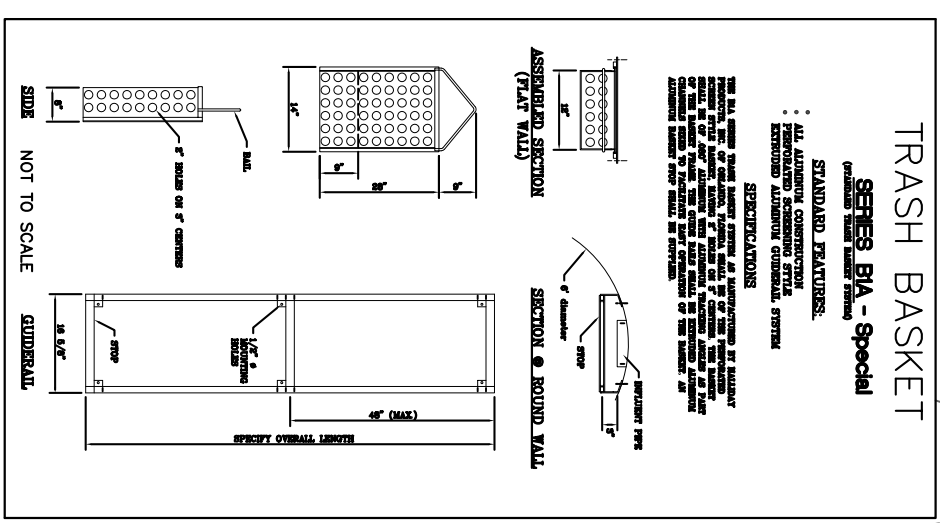

DISCHARGE HOSE DETAIL
NOT TO SCALE

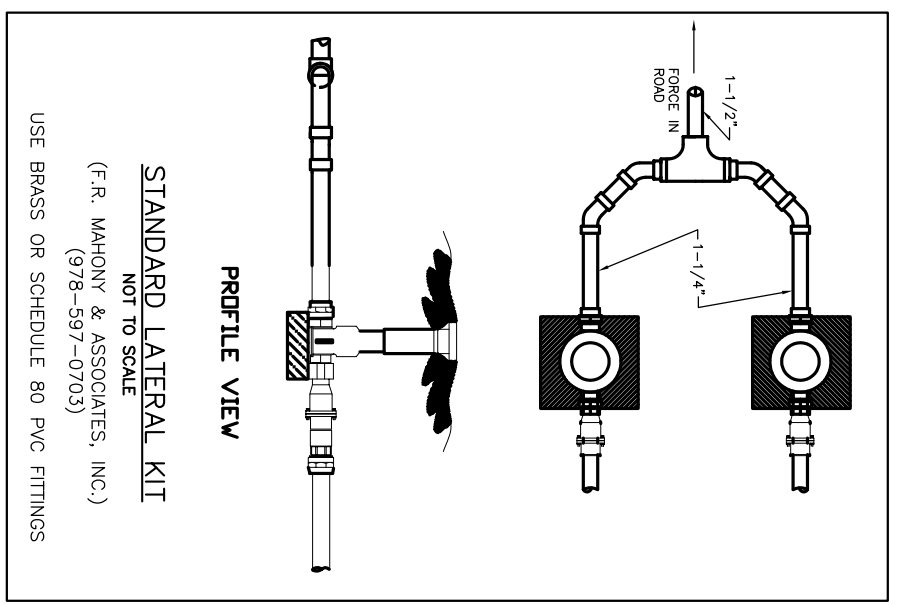

STANDARD LATERAL KIT
NOT TO SCALE
(F.R. MAHONY & ASSOCIATES, INC.)
(978-597-0703)
USE BRASS OR SCHEDULE 80 PVC FITTINGS

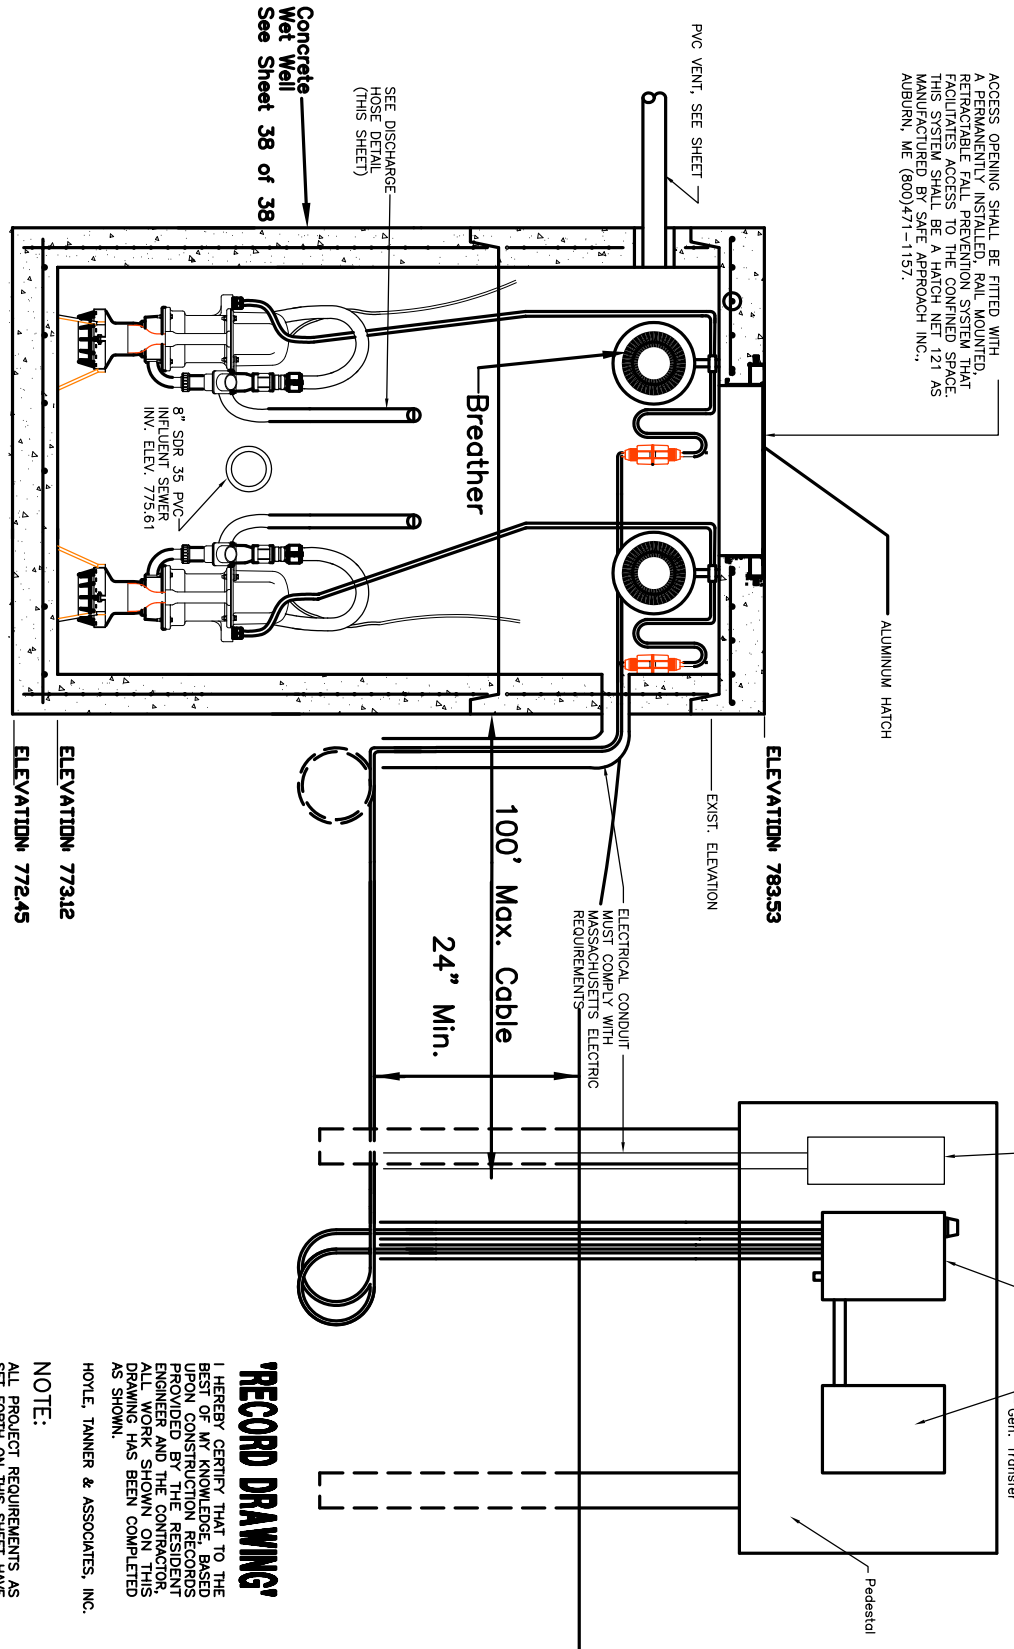

ELEVATION VIEW
NOT TO SCALE

PROJECT NO.	105709	FILE NAME	PL-PUMPSTA
1. RECORD DRAWING	C.B. W.C. W.C. 10/02	DR. BY	CHKD. BY
REV.	DESCRIPTION	APPRO. BY	DATE

HTA Hoyle, Tanner & Associates, Inc.
150 Dow Street • Manchester • New Hampshire 03101
Consulting Engineers

SCALE: AS SHOWN DATE: APRIL 2001 DES. BY JAH DR. BY CAB/RCP CHKD. BY NLT

CHERRY VALLEY SEWER DISTRICT
LEICESTER, MASSACHUSETTS
PLAN AND PROFILE
REDFIELD ROAD
PUMP STA. PLAN/DETAILS

RECORD DRAWING!
I HEREBY CERTIFY THAT TO THE BEST OF MY KNOWLEDGE AND BELIEF, THE INFORMATION CONTAINED HEREON IS TRUE AND CORRECT AND THAT I AM A duly Licensed Professional Engineer in the State of New Hampshire.
NOTE:
ALL PROJECT REQUIREMENTS AS SET FORTH ON THIS SHEET HAVE BEEN COMPLETED DURING THE CONSTRUCTION OF THIS PROJECT. THE CONTRACTOR HAS NOTIFIED ME OF ANY CHANGES TO THE WORK SHOWN ON THIS DRAWING HAS BEEN COMPLETED AS SHOWN.
HOYLE, TANNER & ASSOCIATES, INC.